


LIGHTING PROPOSAL SCALE 1:100

ELEGANT MAX

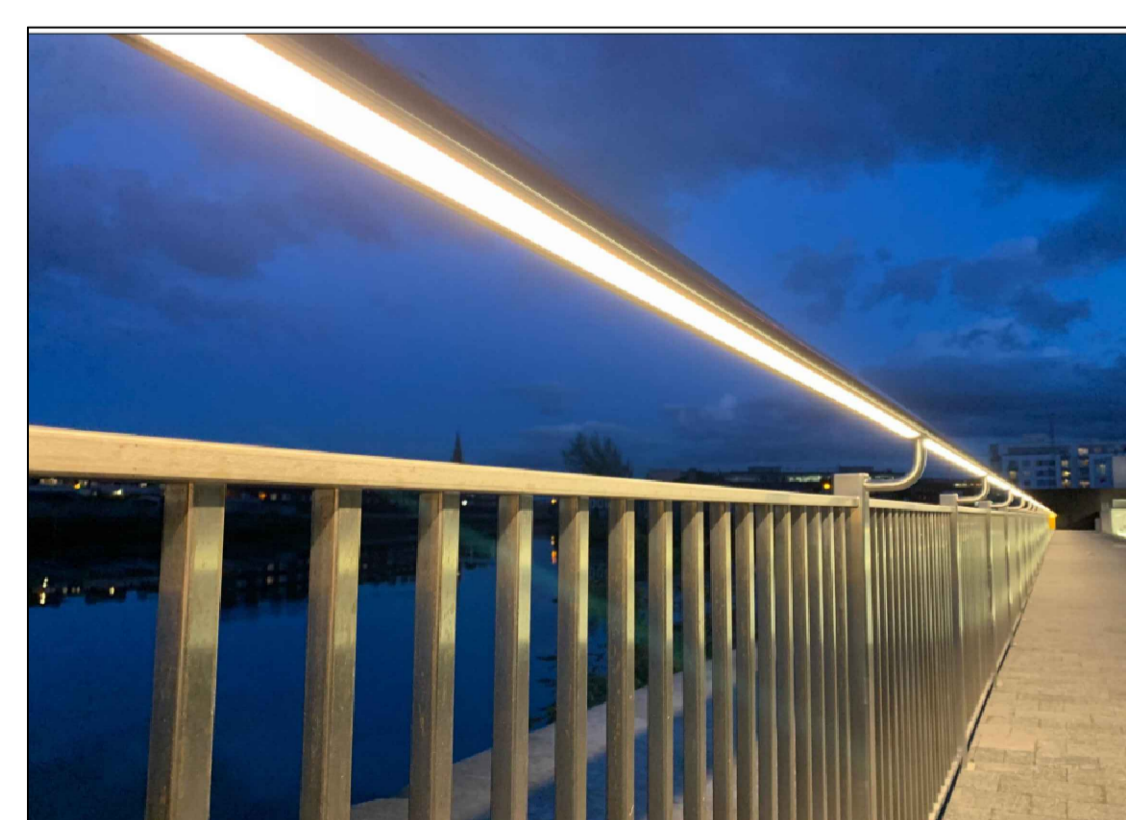

LIGHTING TYPE 04




LIGHTING TYPE 05



LIGHTING TYPE 03



LIGHTING TYPE 01

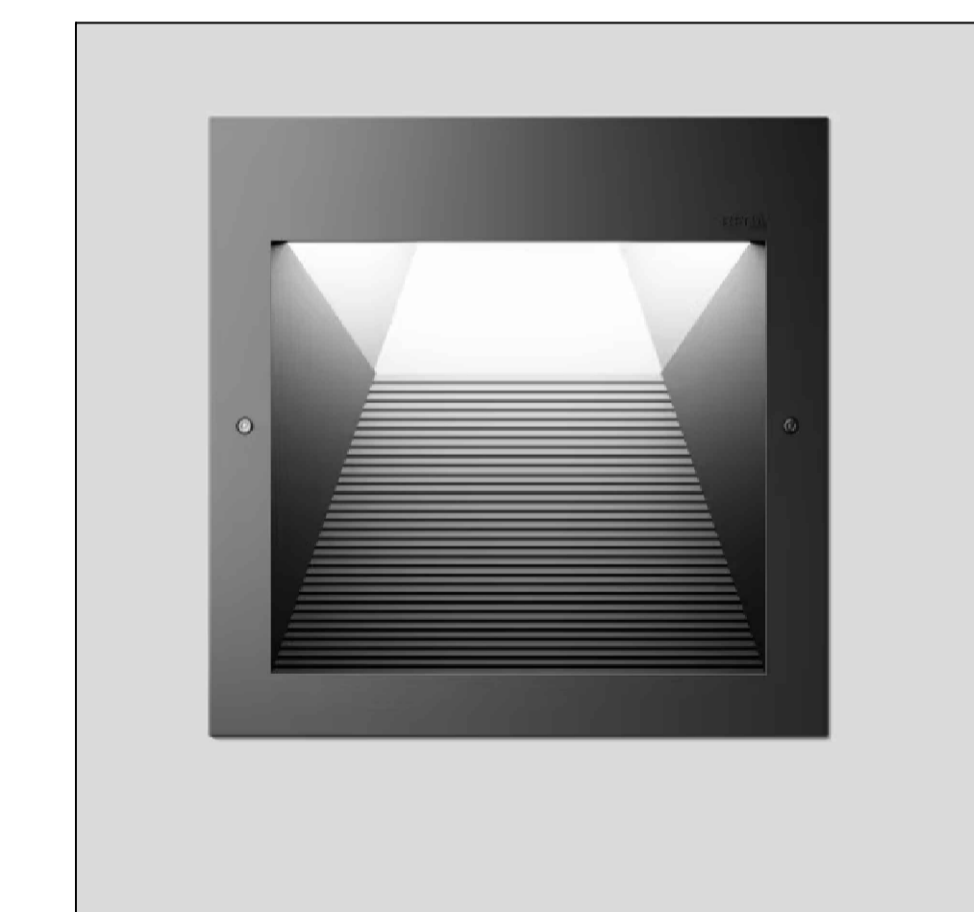


LIGHTING TYPE 02



Arena House, Arena Road, Sandyford, Dublin 18, Ireland
 T: +353 (0) 1 294 0800
 F: +353 (0) 1 294 0820
 www.rod.ie

No.	Revision	Date	By	Chkd	App'd
P01	PLANNING ISSUE	16/01/2025	APL	DM	CK

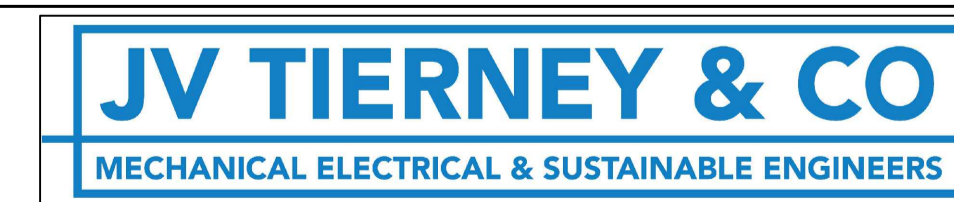

The Tannery, 53-56 Cork Street, Dublin D08 P92R, Ireland
 T: +353 1 421 4900 E: mail@jvtierney.ie W: www.jvtierney.ie
 ISO 45001:2018 I.S. EN ISO 9001:2015 I.S. EN ISO 14001:2015

Drawn	Designed	Checked	Approved	Suitability Code - Description
APL	DM	CH	CK	S2 - Information/Planning

Project Stage		PLANNING			
Project Title		WATERFORD CITY PUBLIC INFRASTRUCTURE PROJECT			
Drawing Title		TRANSPORT HUB SOUTHERN SERVICES LIGHTING PLANNING SUBMISSION			
Drawing Number	Project	Originator	Volume	Location	Type Role Number
WPIP	-	JVT	-	Z1 - 02	- DR - E - 6990
Scale (A1)	1:100	Date:	NOVEMBER 2024	Job No:	18.141
				Rev:	P01