


Notes:  
 This drawing is used for indicative purposes only. It should not be used for scaling under any circumstances. The contractor shall agree the exact locations of all equipment with the relevant parties - Client, Architect or Builder.

The contractor shall co-ordinate his services with all other trades prior to commencement of any works on site.

Discrepancies or contradictions in the information indicated on the drawings and contained in the specification should be brought to the Engineers attention and agreement reached before any works commence.

LEGEND:

- ER — Electrical Riser
- PR — Electrical Plant Room
- PR — Mechanical Plant Room

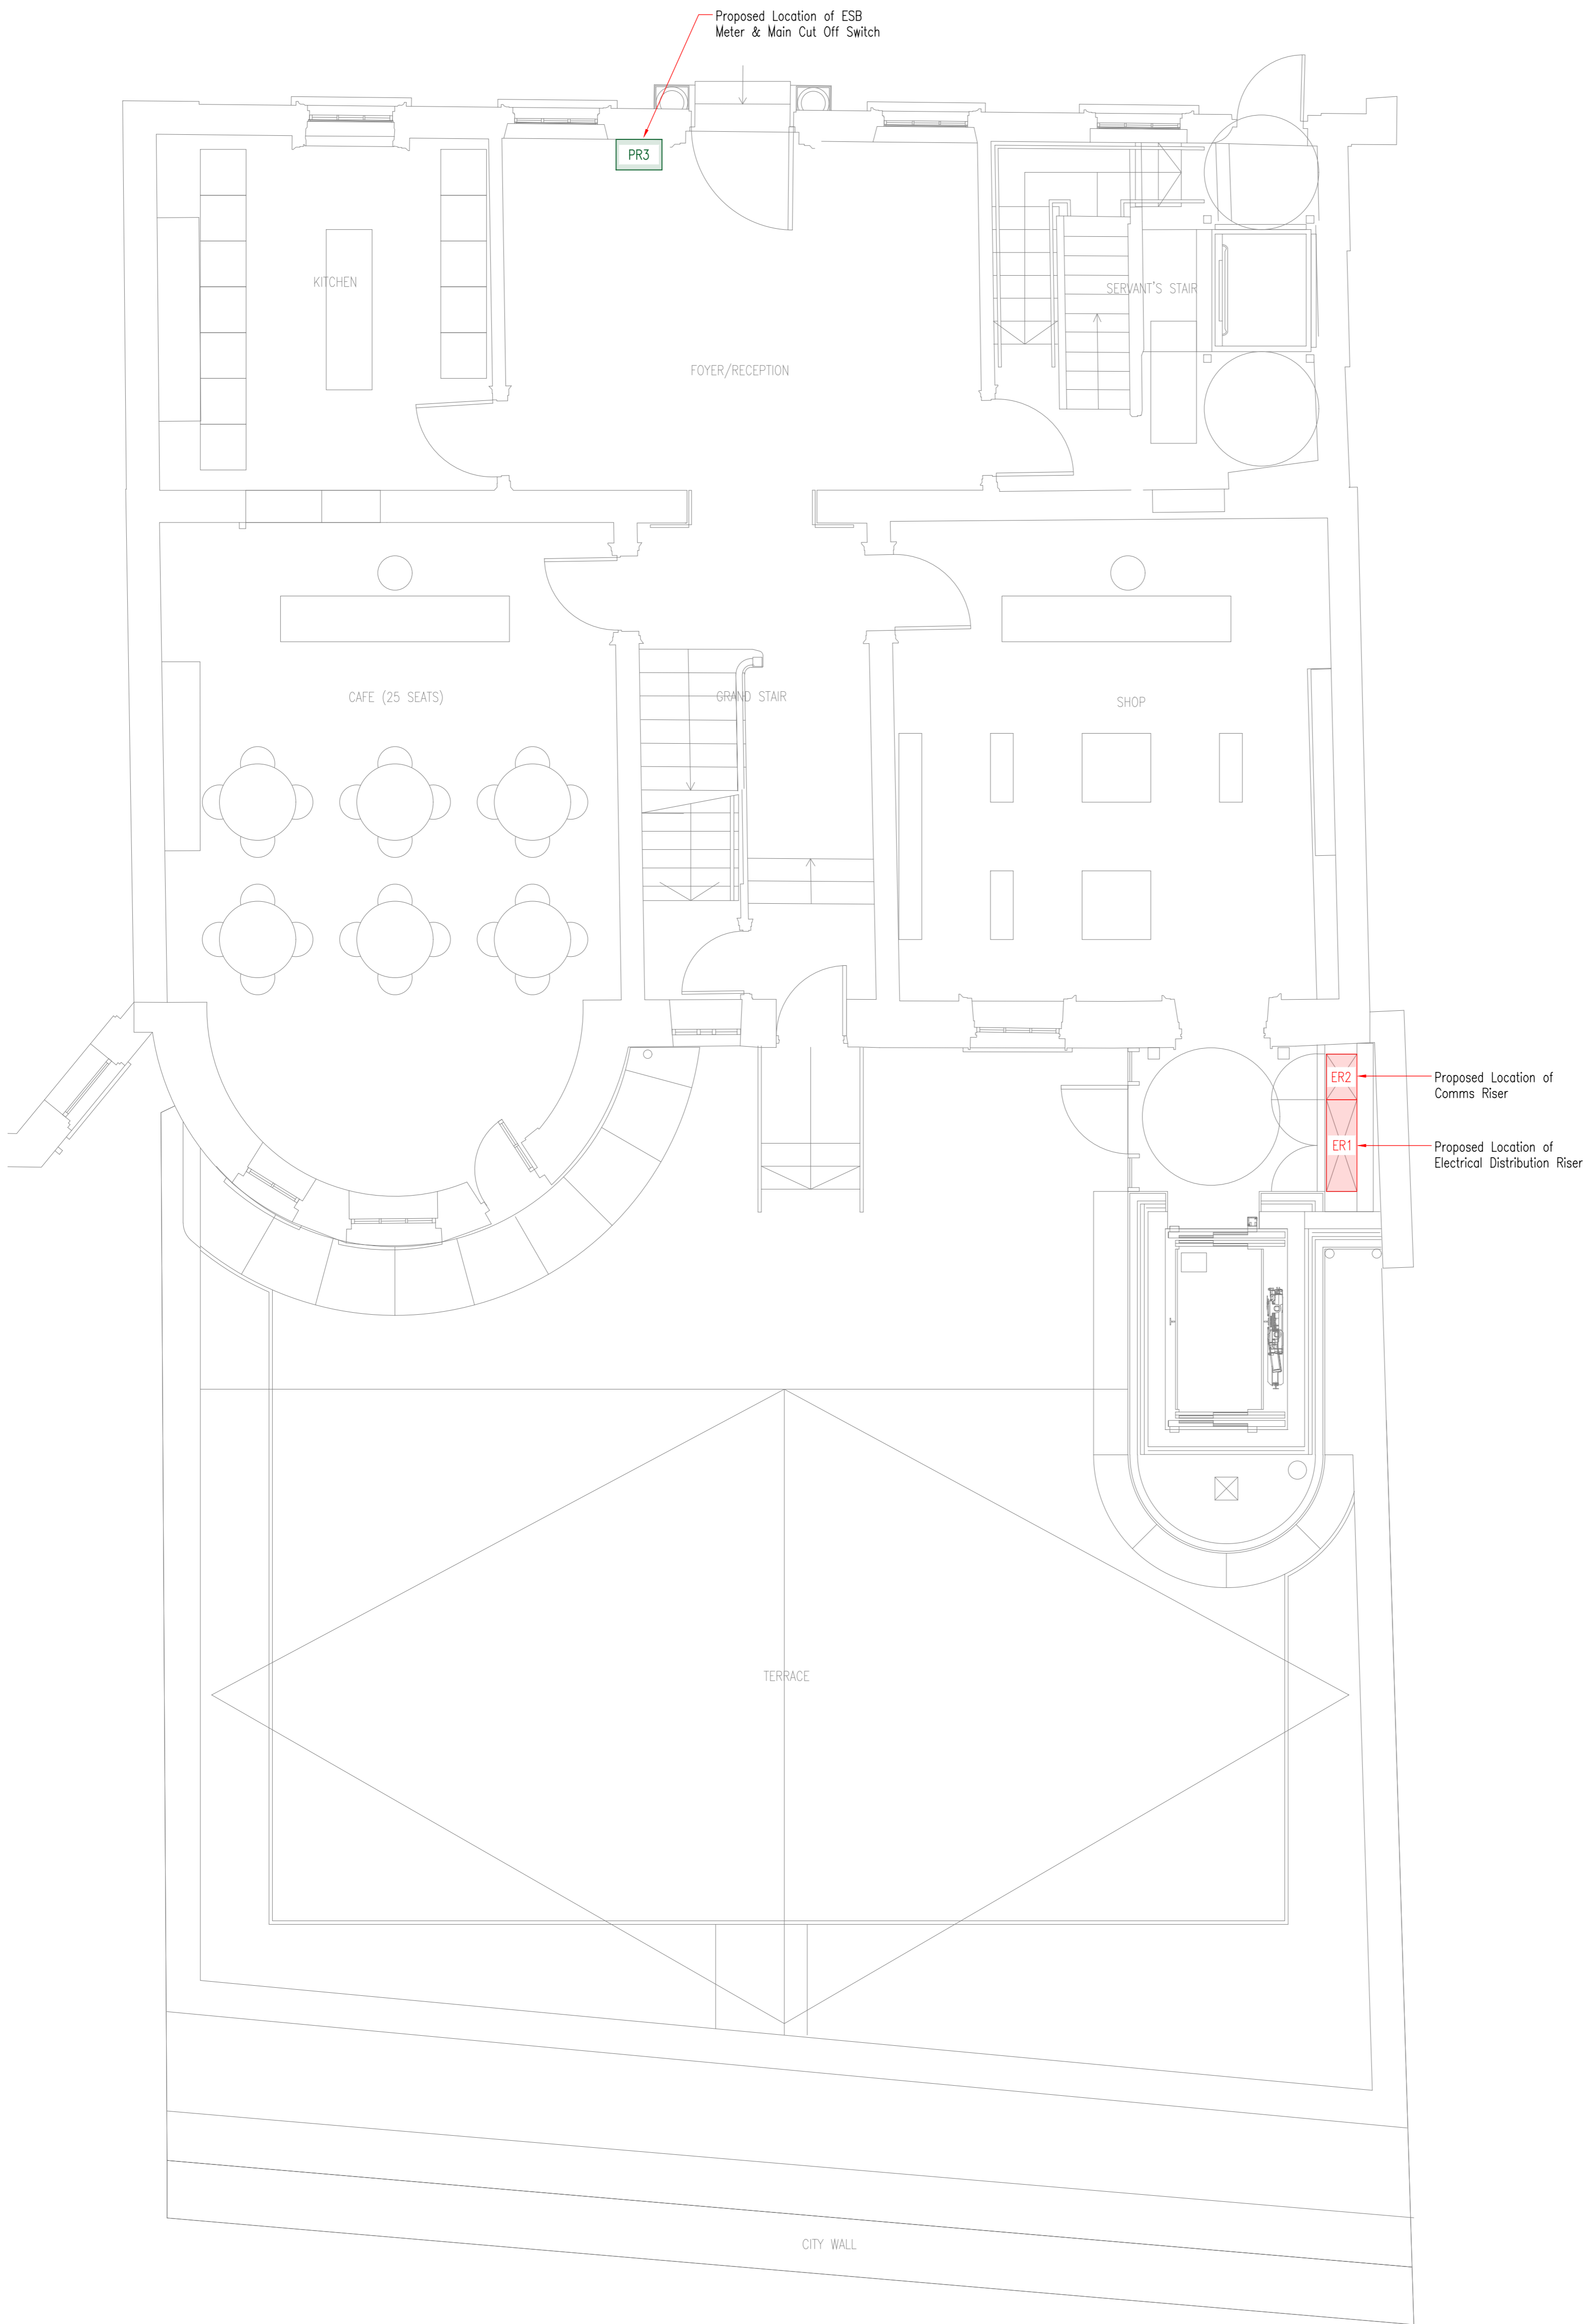


P2	10/07/25	PLANNING ISSUE	AN	ML
P1	05/06/25	PRELIMINARY ISSUE	AN	ML
P	27/11/24	PRELIMINARY ISSUE	RV	ML
REV	DATE	DESCRIPTION	DRAWN	CHECKED

**DO NOT SCALE**

This drawing is representative only.  
 To be read in conjunction with Architects drawings.

CONSULTING ENGINEER:

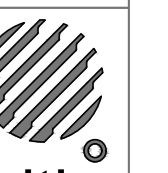

**Bernard Smith**  
 Consulting Engineers

Bernard Smith Consulting Engineers  
 Bracelown Business Park | Clonee | Dublin 15  
 t: 01-801 4127 | w: www.bernardsmith.ie | e: info@bernardsmith.ie

PROJECT:

**FORMER MEN'S HOSTEL  
 18 LADY LANE  
 CO. WATERFORD**

TITLE:

**PRELIMINARY MEP ACCOMODATION  
 GOUND FLOOR**

SCALE: 1:50@A1 / 1:100@A3	DRAWN BY: AN	JOB NO.: 24-063	DWG NO.: PSR-00	REV.: P2
DATE: 25/11/2024	CHECK'D: ML			

**PLANNING**