


USE FIGURED DIMENSIONS ONLY

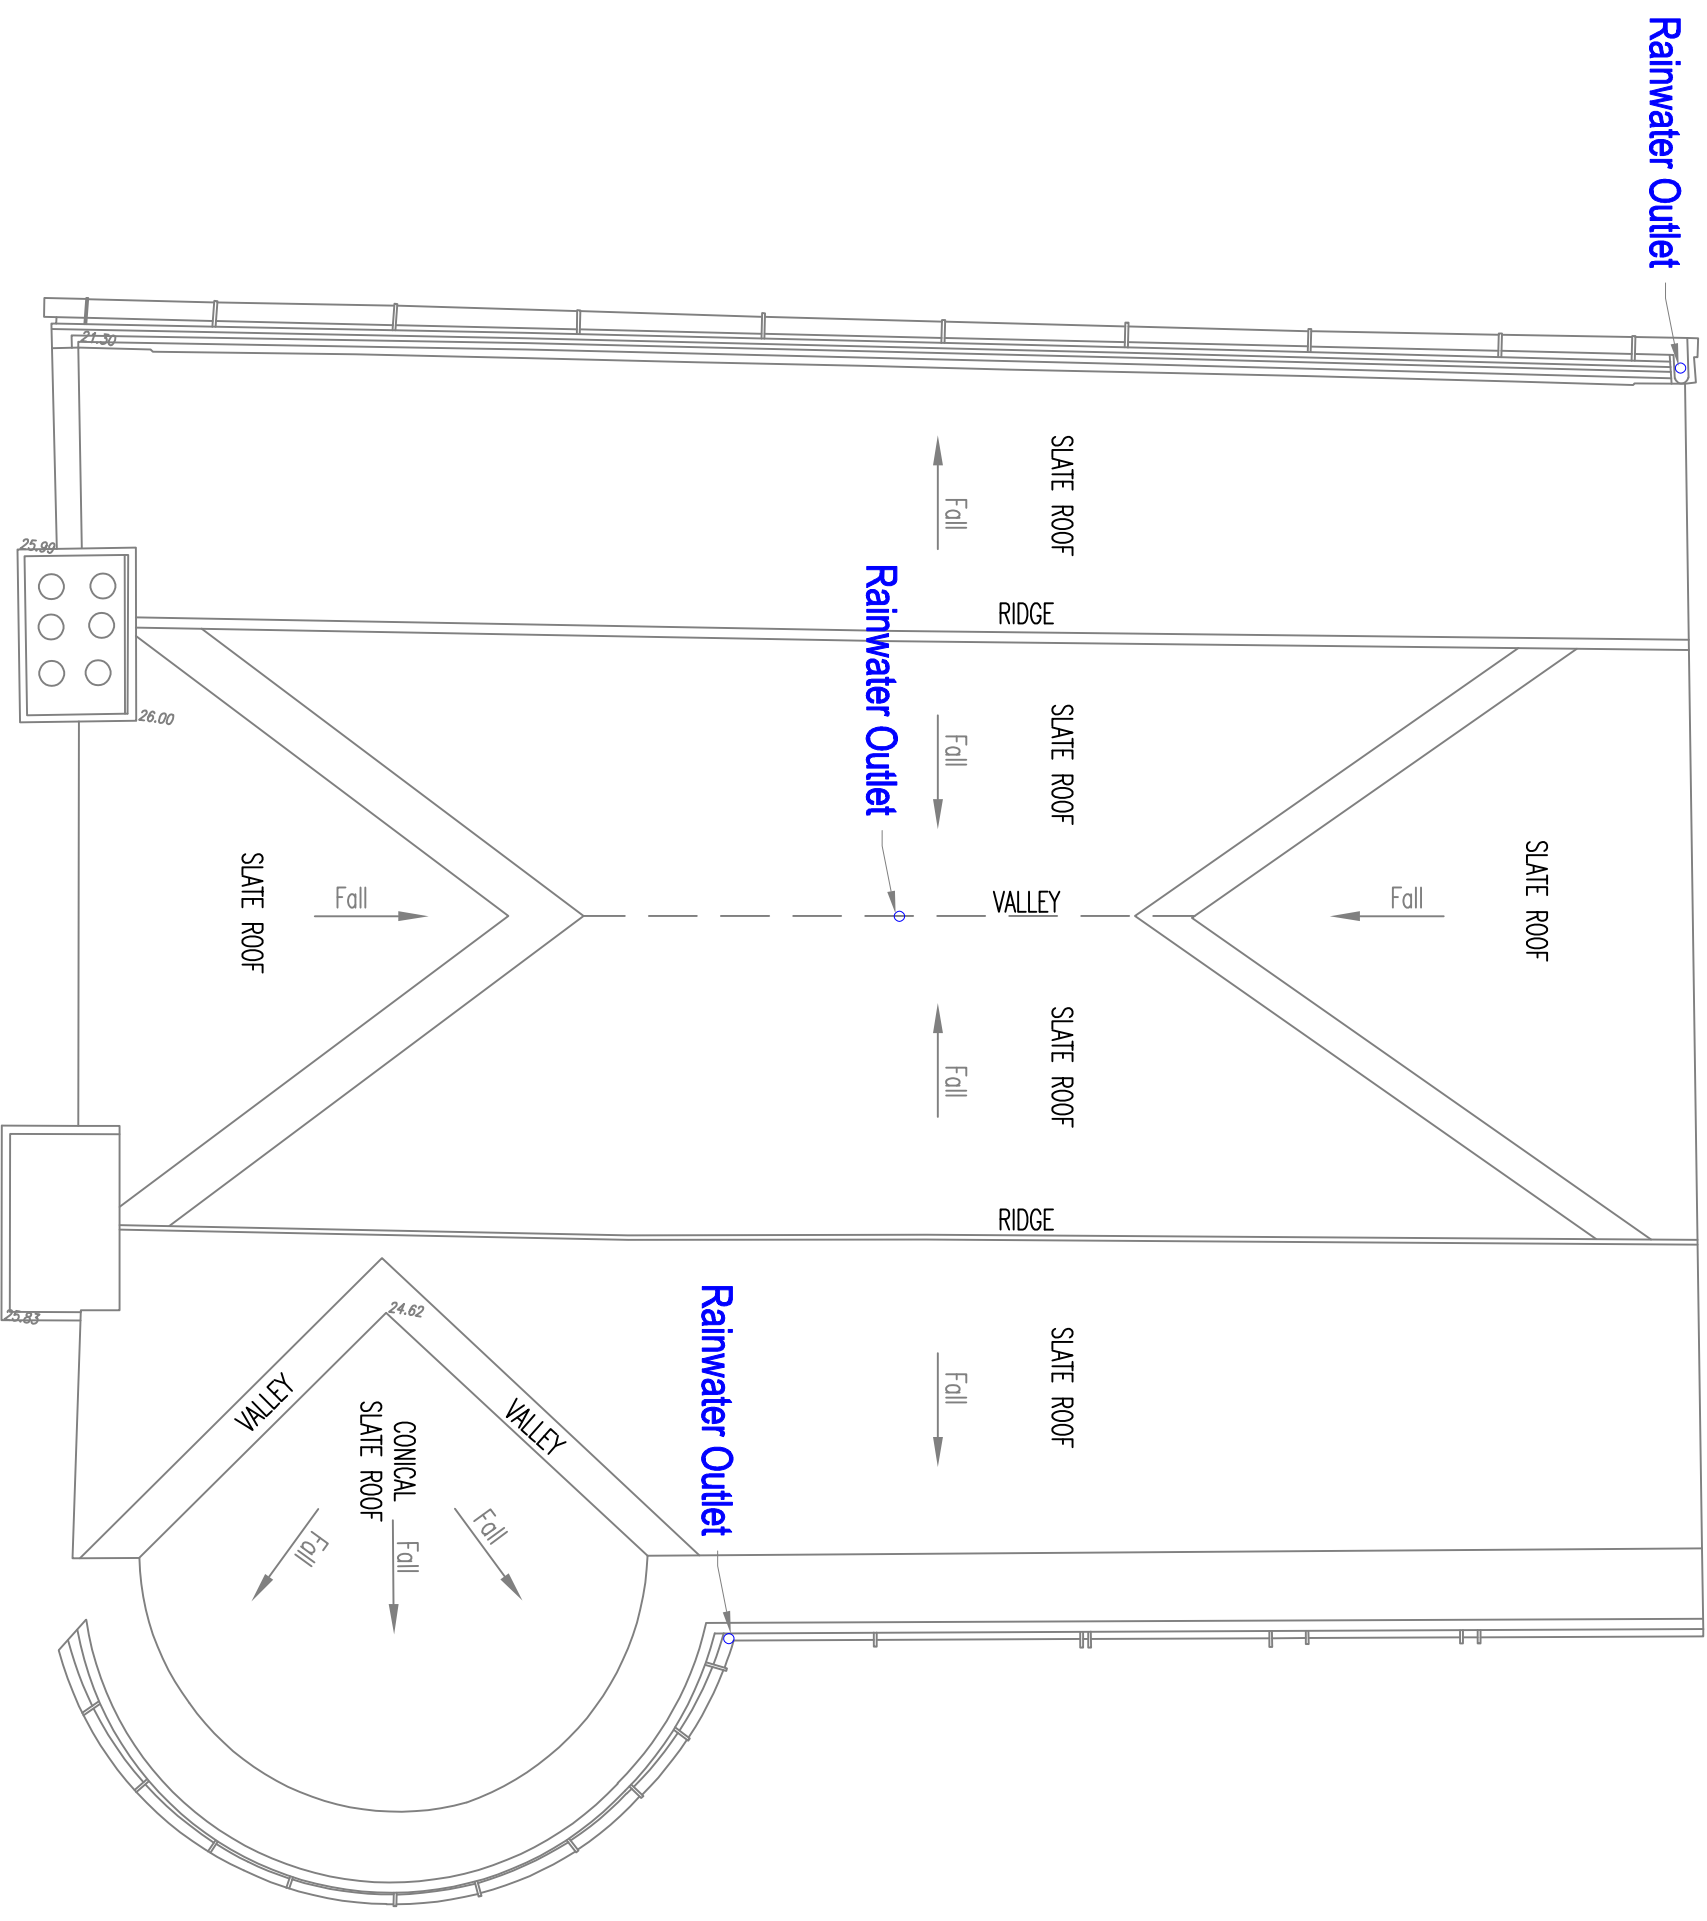

ROOF LAYOUT OF RETAINED PROTECTED STRUCTURE SHOWING RAINWATER OUTLETS


ALL DIMENSIONS TO BE CHECKED BY THE CONTRACTOR ON SITE. ANY ERRORS OR DISCREPANCIES TO BE REPORTED TO THE ENGINEER IN CHARGE

NOTES

1. Drawings to be read in conjunction with all relevant Architects, Engineers and specialist drawings.
2. Do not scale, use given dimensions only. All dimensions are in millimeters except where shown.
3. Inform the Engineer of any discrepancies prior to proceeding with works.
4. This drawing should be printed in colour for clarity.
5. All levels to ordnance datum.
6. All connections, bedding etc. is to be done strictly in accordance with Irish Water specifications & details.

LEGEND

	Existing Public Combined Sewer
	Existing Private Foul Sewer
	Existing Private Foul Sewer Manhole
	Existing Private Combined Sewer
	Existing Stormwater Sewer
	Existing Stormwater Downpipe
	Site Boundary

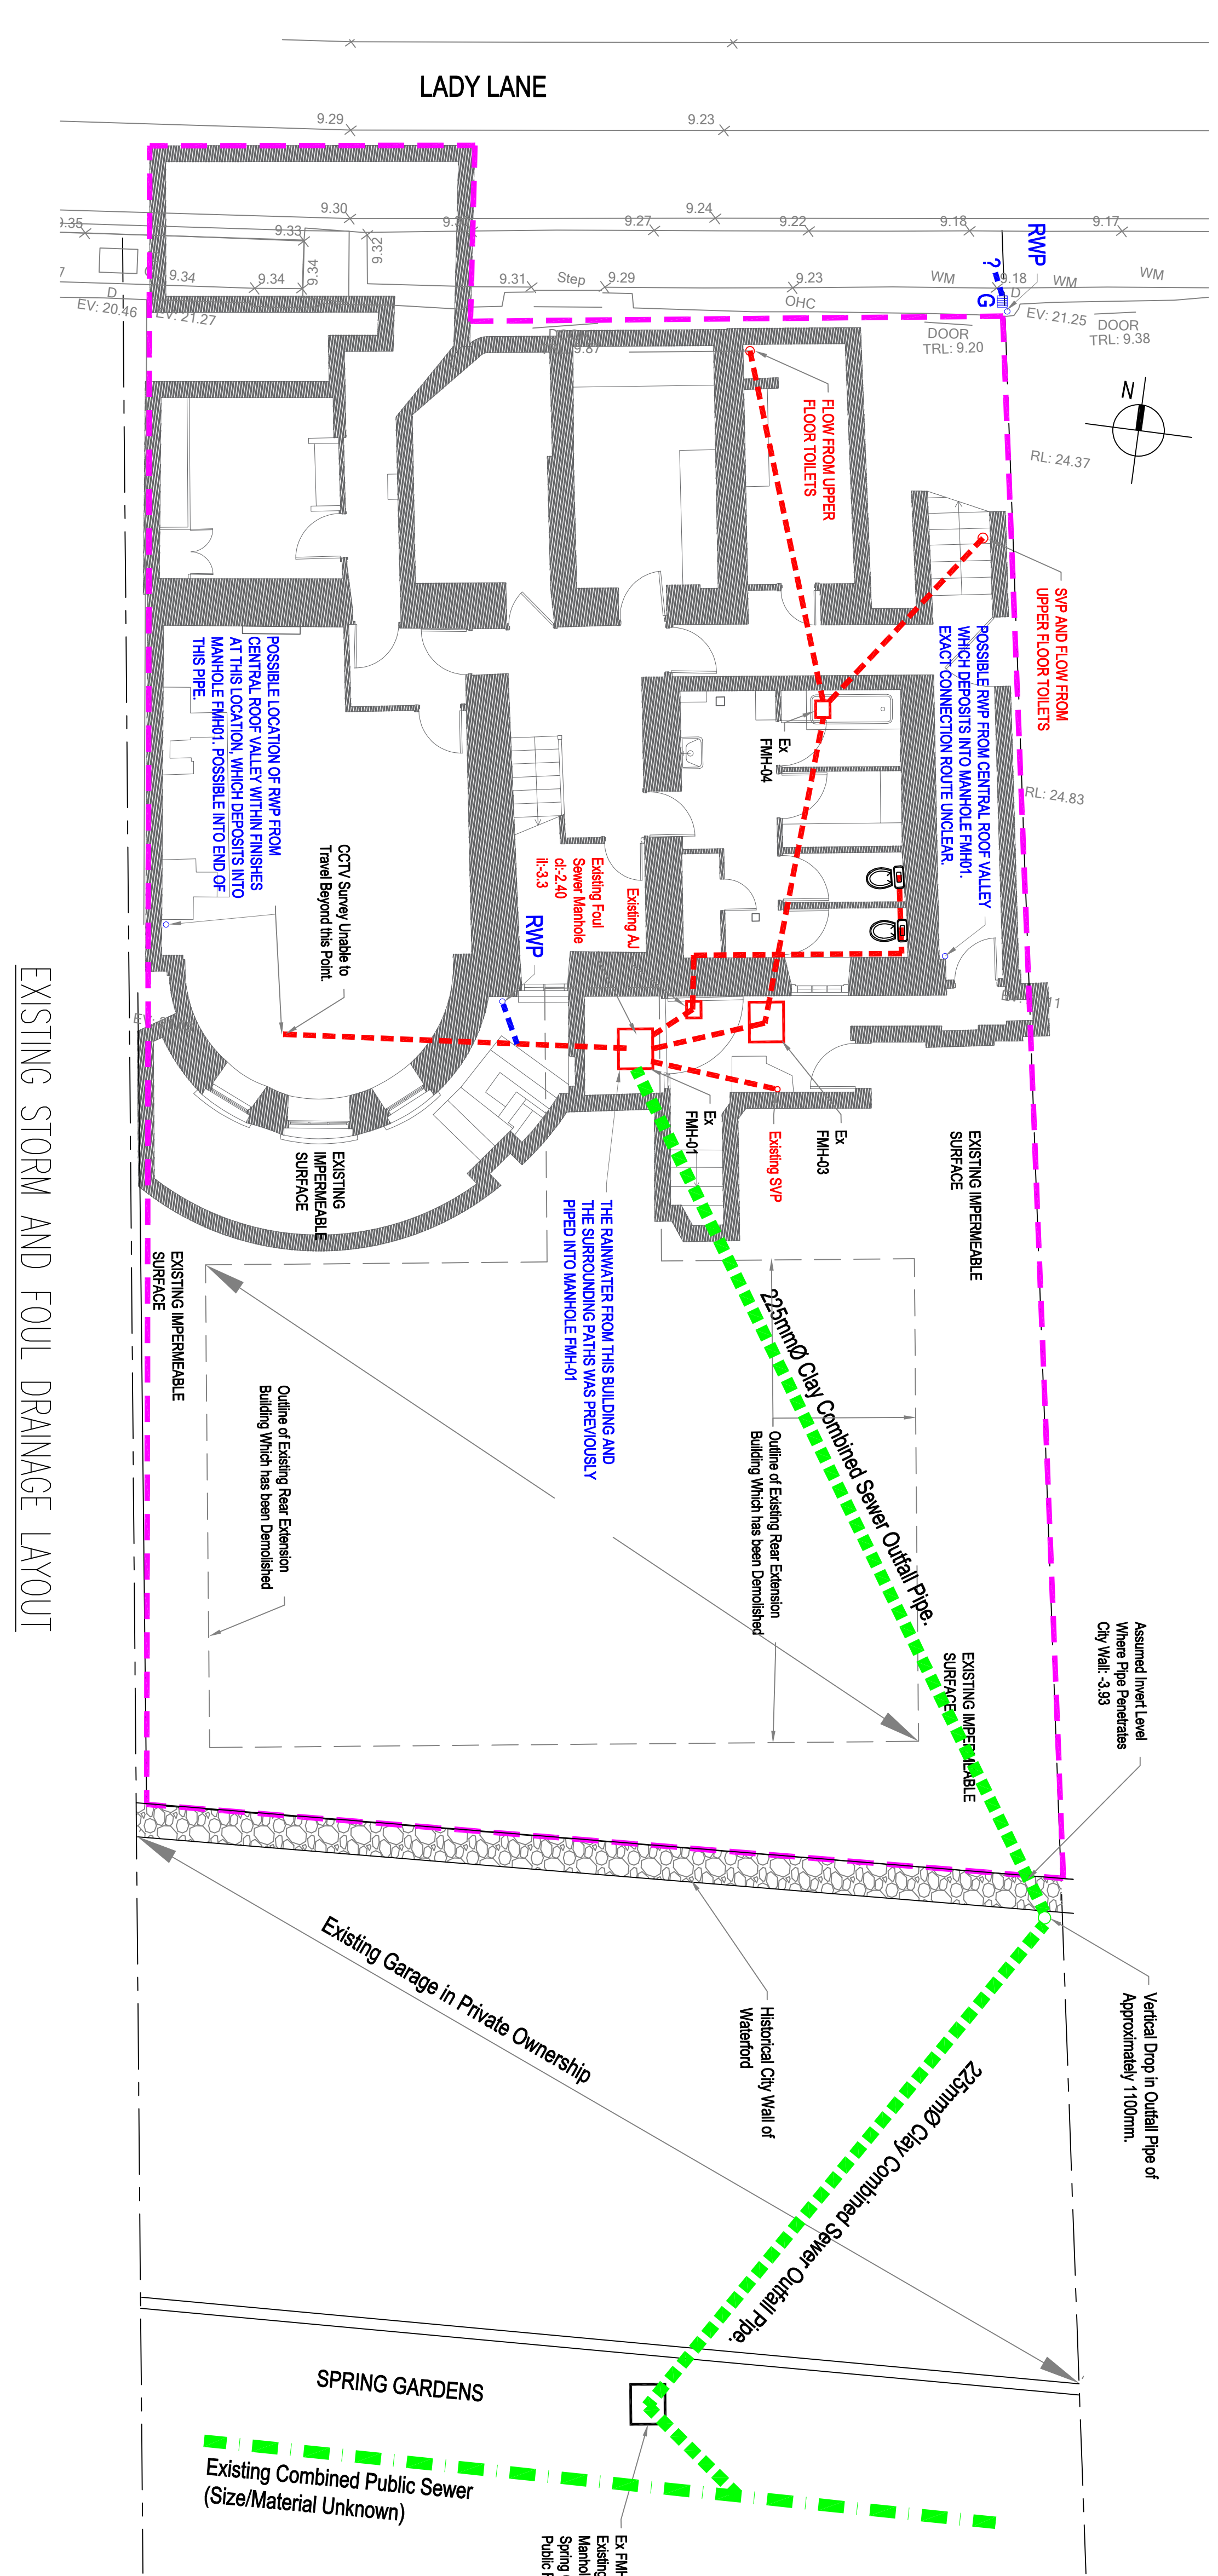

EXISTING STORM AND FOUL DRAINAGE LAYOUT

Rev.	Date	Description	By	Check
P3	27.01.2026	LINE OF EXISTING OUTFALL PIPE REVISED	CW	NI
P2	17.06.2025	LINE OF EXISTING OUTFALL PIPE REVISED	CW	NI
P1	11.06.2025	ISSUED FOR INFORMATION	CW	NI

THIS DRAWING IS COPYRIGHT © M S C R A E CONSULTING ENGINEERS. NO PART OF THIS DRAWING MAY BE REPRODUCED OR TRANSMITTED IN ANY FORM OR BY ANY MEANS WITHOUT THE WRITTEN PERMISSION OF M S C R A E CONSULTING ENGINEERS EXCEPT AS AUTHORIZED FOR USE ON THE PROJECT FOR WHICH THE DRAWING WAS ORIGINALLY ISSUED.

**PLANNING**

Project Name: 18 LADY LANE  
 Drawing Title: EXISTING FOUL AND STORMWATER DRAINAGE LAYOUTS  
 Architect: HENEAGHAN PENG ARCHITECTS  
 Client: WATERFORD TREASURES

Drawn: RM  
 Checked: RM  
 Approved: RM  
 Scale: 1/75

**M S C R A E**  
 CONSULTING ENGINEERS

FINE CIVIL & STRUCTURAL CONSULTING ENGINEERS  
 REGISTERED ARCHITECTS IN IRELAND  
 TEL: 01 282 2599  
 WWW.MSCRAE.COM

Project No: Originator: Volume: Level: Type: Role: Number: Rev:  
 5751 - MCE - 00 - XX - DR - C - 0104 - P3